


2ND FLOOR LAYOUT
SCALE: 1/4" = 1'-0"

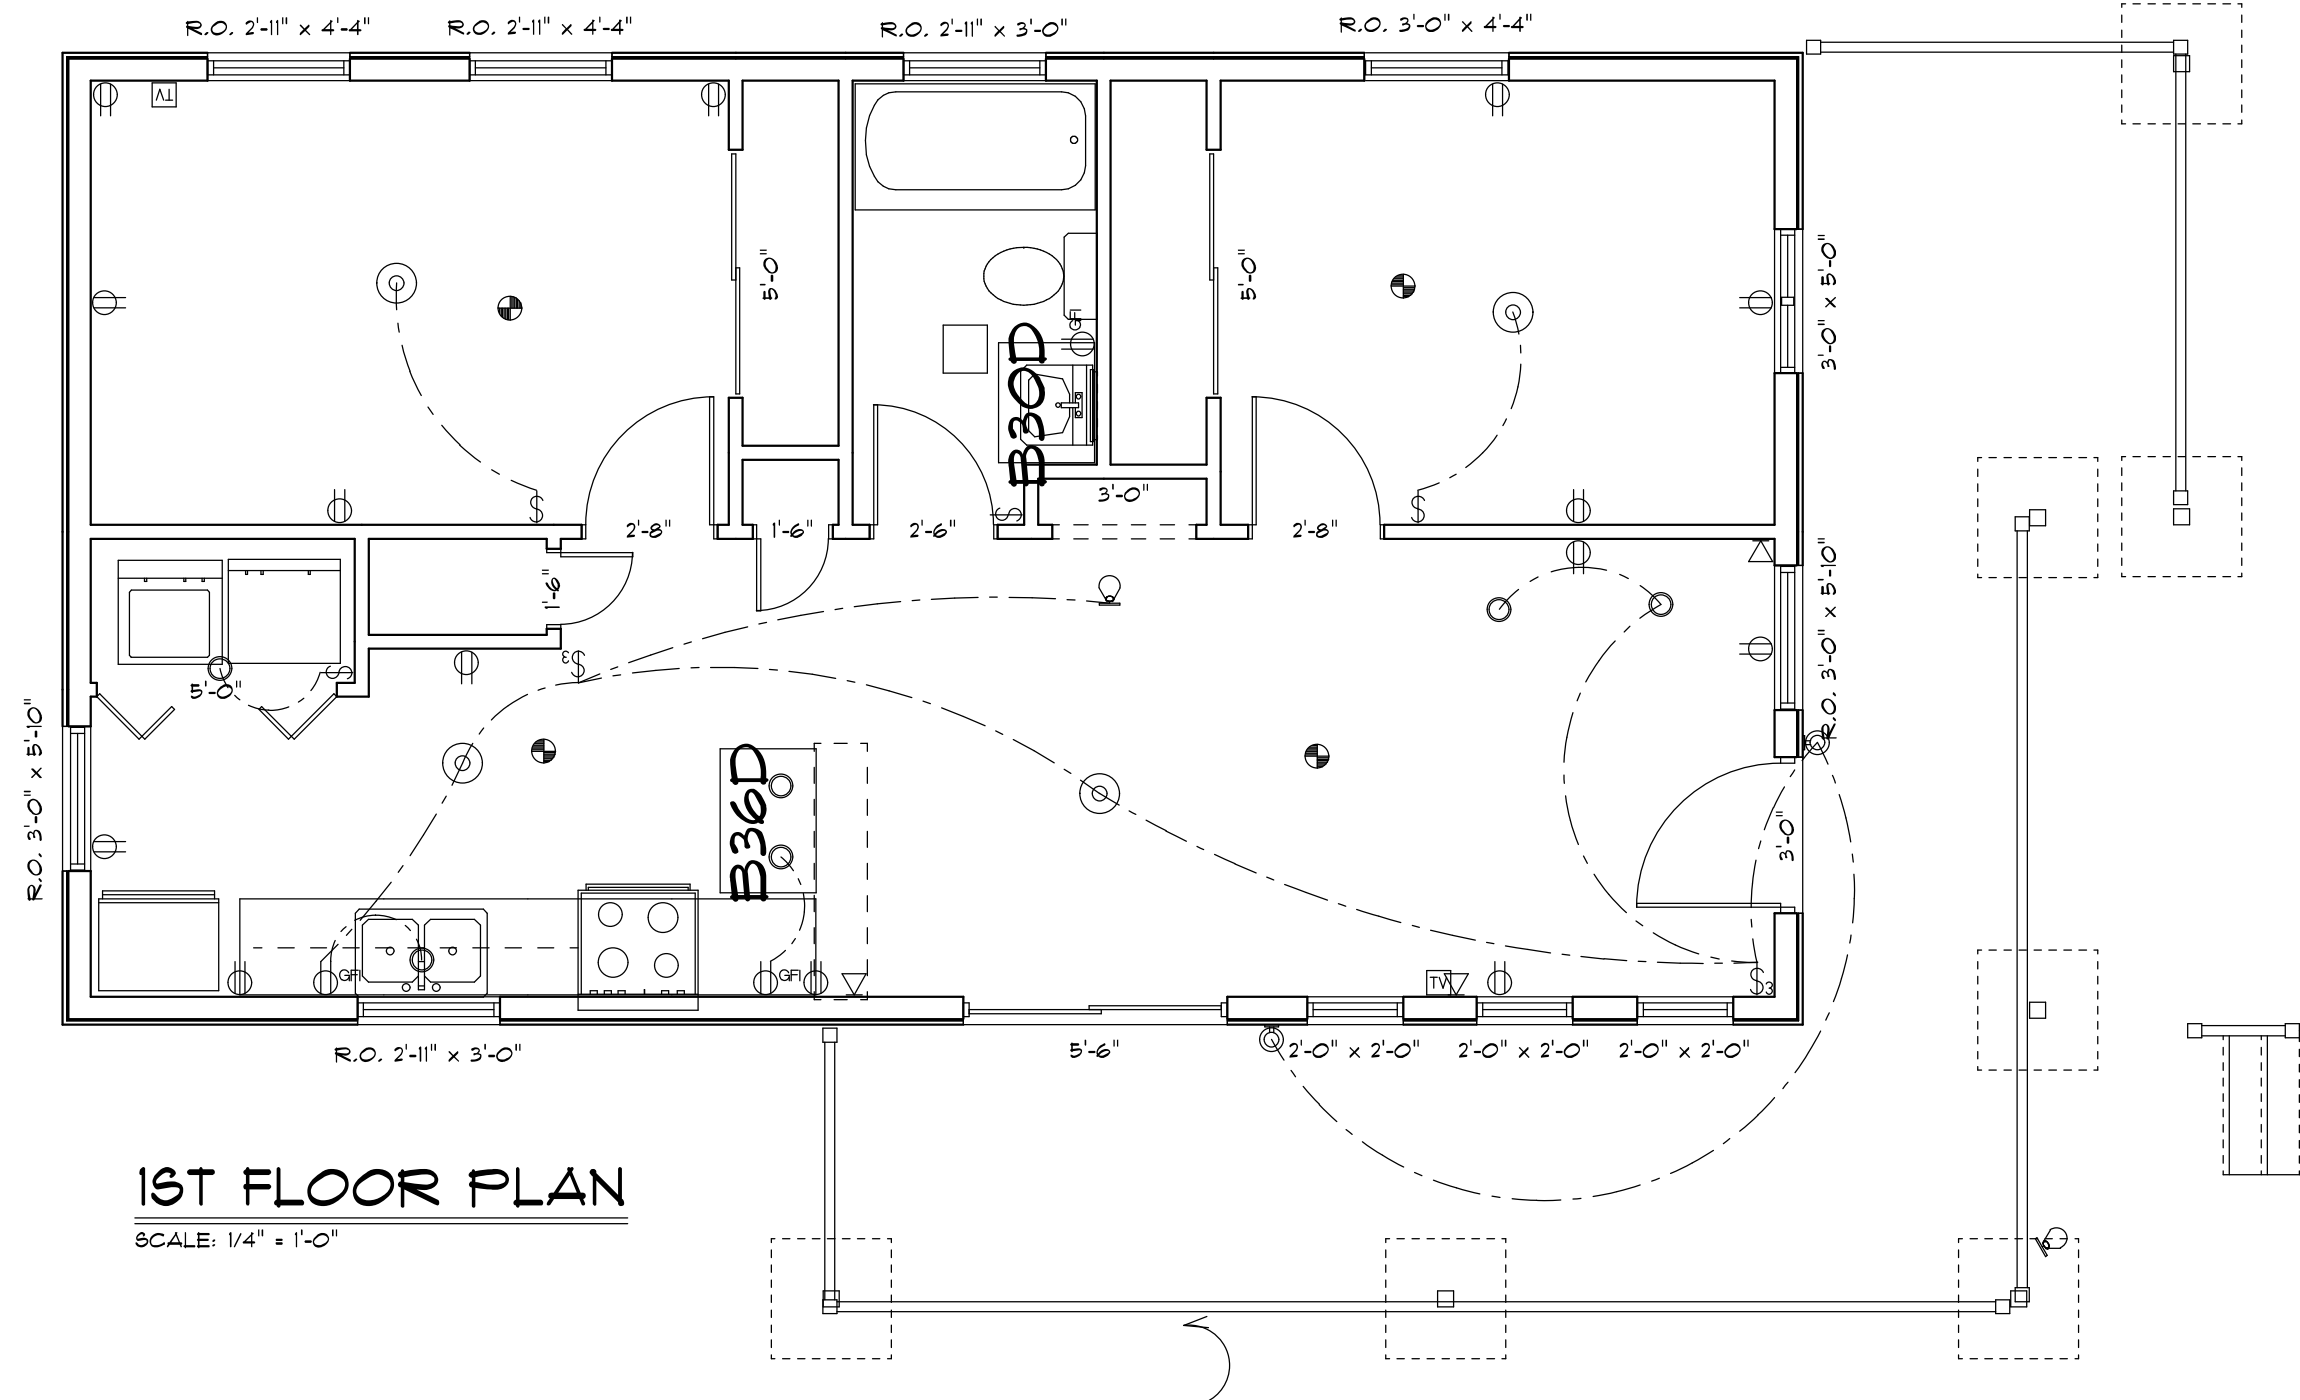

1ST FLOOR PLAN
SCALE: 1/4" = 1'-0"

ELECTRICAL	COUNT	SYMBOL
ceiling lamp globe	3	○
ceiling lamp square	1	◻
ceiling light vent square	2	◻
ceiling globe light	4	⊙
double spotlight	1	⊕
pot light	11	○
single spotlight	2	⊕
track light	1	—○—○—
wall mount 1	4	⊕
cable tv outlet	4	◻
outlet	28	⊕
outlet gfi	6	⊕GFI
smoke detector	8	⊕
switch	9	⌞
switch 3 way	5	⌞3
telephone	6	▽

STREET